



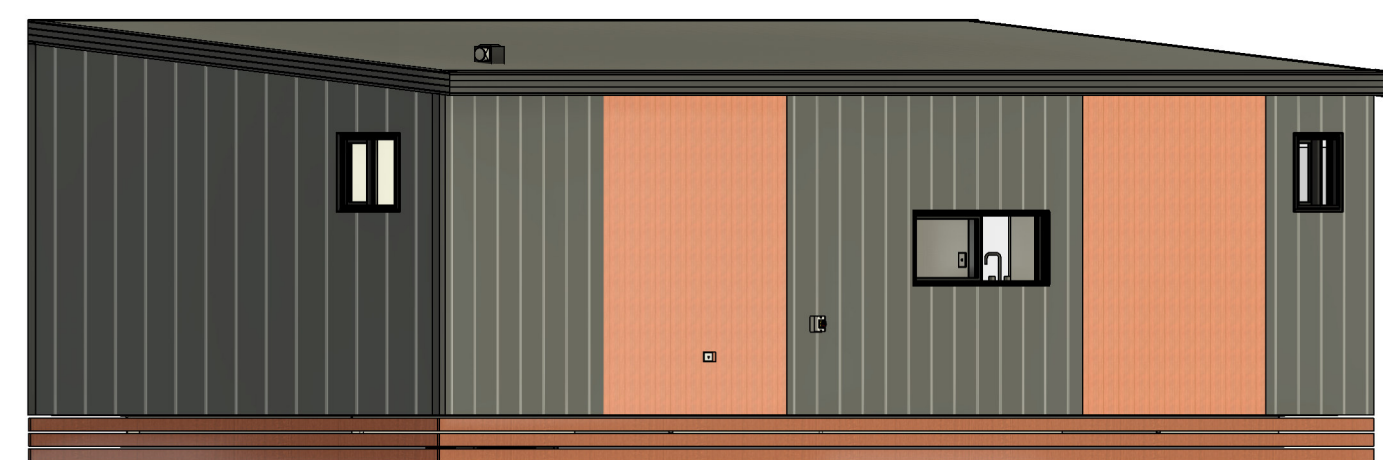

'MODERN'
CLADDING
THEME SHOWN

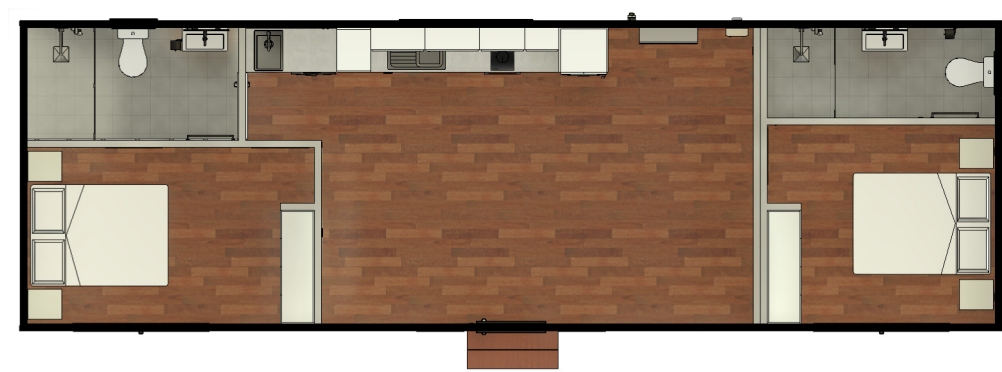

DRAWING LIST

SHEET NUMBER	SHEET NAME	CURRENT REVISION
A000	TITLE PAGE	B
A101	FLOOR PLAN	B
A102	ELEVATIONS 1 OF 2	B
A103	ELEVATIONS 2 OF 2	B
A104	SECTION & INTERNAL 3D VIEWS	B
A105	JOINERY DETAILS, KITCHEN & LAUNDRY	B
A111	ELECTRICAL LAYOUT - PART 1	B
A112	ELECTRICAL LAYOUT - PART 2	B
A113	PLUMBING LAYOUT	B
A120	SCHEDULES	B

ORANA

13.0 x 4.1m 2 BEDROOM CABIN

'THE ESPERANCE'

ORANA

14729 Spring Avenue,
Santa Fe Springs, CA, 90670
E: hello@oranausa.com
P: 888 256 6416

WIND REGION:		
TERRAIN CATEGORY:		
IMPORTANCE LEVEL:		
SHIELDING FACTOR:		
BUILDING CLASS:		1a
FLOOR	DISTRIBUTED (kPa):	1.5
LOADS	CONCENTRATED (kN):	1.2
CLIMATE ZONE:		



NORTH

FLOOR LOADS CALCULATED FROM AS1170.1 - 2002. WIND SPEED CALCULATED FROM AS1170.2 - 2011. BUILDING CLASS, IMPORTANCE LEVEL, PROBABILITY OF EXCEEDANCE, WIND REGION, TERRAIN CATEGORY, TOPOGRAPHIC CLASIFICATION, SHIELDING FACTOR, CLIMATE ZONE & NORTH POINT ARE ASSUMED UNLESS OTHERWISE ADVISED BY CLIENT.

ELECTRICAL SYMBOL LEGEND

	ELECTRICAL SWITCHBOARD		GPO, 1 x 10AMP
	ELECTRICAL POINT OF ENTRY		GPO, 2 x 10AMP
	LIGHT SWITCH, SINGLE		20AMP AC ISOLATION SWITCH
	LIGHT SWITCH, TWO GANG		LED DOWNLIGHT
	LIGHT SWITCH, THREE GANG		240V SMOKE ALARM
	FAN/ LIGHT SWITCH		

SET OUTS, LEVELS AND CRITICAL DIMENSIONS TO BE CONFIRMED ON SITE PRIOR TO FABRICATION
DO NOT SCALE FROM THIS DRAWING, USE FIGURED DIMENSIONS
ALL CONSTRUCTION TO COMPLY WITH NATIONAL CONSTRUCTION CODE OF AUSTRALIA (NCC) AND RELEVANT AUSTRALIAN STANDARDS
ALL DESIGNS © AJC PORTABLES, 2024

REVISION SCHEDULE

REV	DESCRIPTION	DATE	BY
A	ISSUED FOR REVIEW	28.03.26	DM
B	ADDED ELECTRICAL LAYOUT & PLUMBING LAYOUT	07.08.26	BV

DRAWING STATUS

ISSUED FOR REVIEW

ORANA

14729 Spring Avenue,
Santa Fe Springs, CA, 90670
E: hello@oranausa.com
P: 888 256 6416

BUILDING NAME

'THE ESPERANCE'

DESCRIPTION

13.0 x 4.1m 2 BEDROOM CABIN

CLIENT

ORANA

SHEET TITLE

FLOOR PLAN

DRAWING NUMBER


A101

REVISION

B


SCALE AT A3
As indicated

12-Aug-26 8:22:03 AM

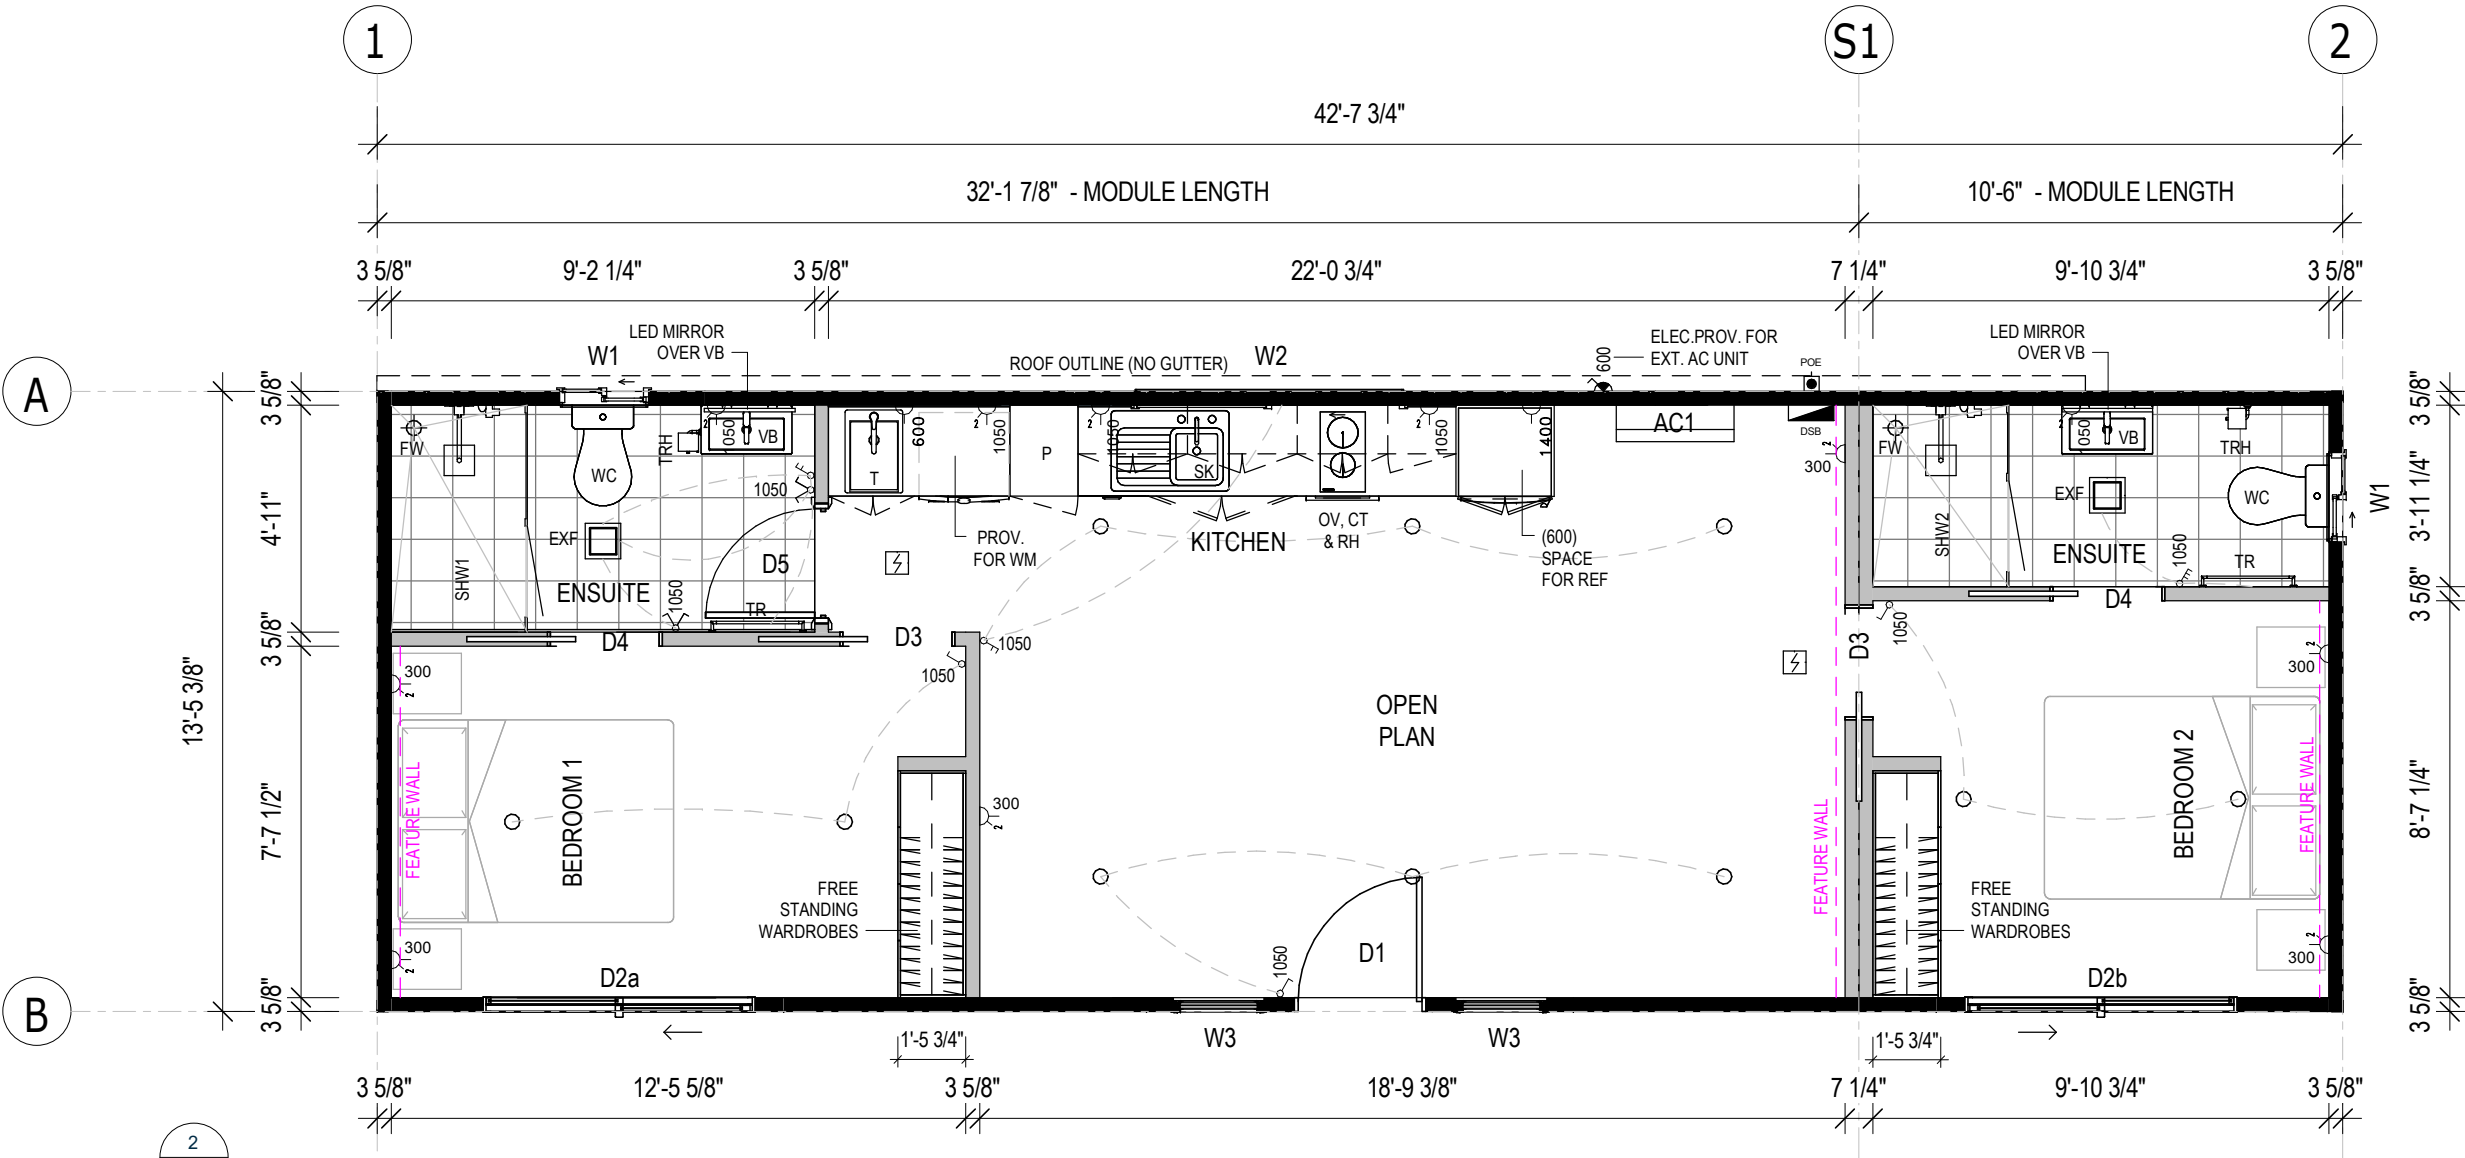

FLOOR PLAN

1 : 50

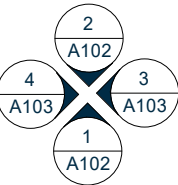

ELEVATION
KEY GUIDE

SET OUTS, LEVELS AND CRITICAL DIMENSIONS TO BE
CONFIRMED ON SITE PRIOR TO FABRICATION
DO NOT SCALE FROM THIS DRAWING, USE FIGURED
DIMENSIONS
ALL CONSTRUCTION TO COMPLY WITH NATIONAL
CONSTRUCTION CODE OF AUSTRALIA (NCC) AND
RELEVANT AUSTRALIAN STANDARDS
ALL DESIGNS © AJC PORTABLES, 2024

REVISION SCHEDULE			
REV	DESCRIPTION	DATE	BY
A	ISSUED FOR REVIEW	28.03.26	DM
B	ADDED ELECTRICAL LAYOUT & PLUMBING LAYOUT	07.08.26	BV

DRAWING STATUS

ISSUED FOR
REVIEW

ORANA

14729 Spring Avenue,
Santa Fe Springs, CA, 90670
E: hello@oranausa.com
P: 888 256 6416

BUILDING NAME

'THE ESPERANCE'

DESCRIPTION

13.0 x 4.1m 2 BEDROOM
CABIN

CLIENT

ORANA

SHEET TITLE


ELEVATIONS 1 OF 2

DRAWING NUMBER

A102

REVISION
B
SCALE AT A3
1 : 50


12-Aug-26 8:22:04 AM

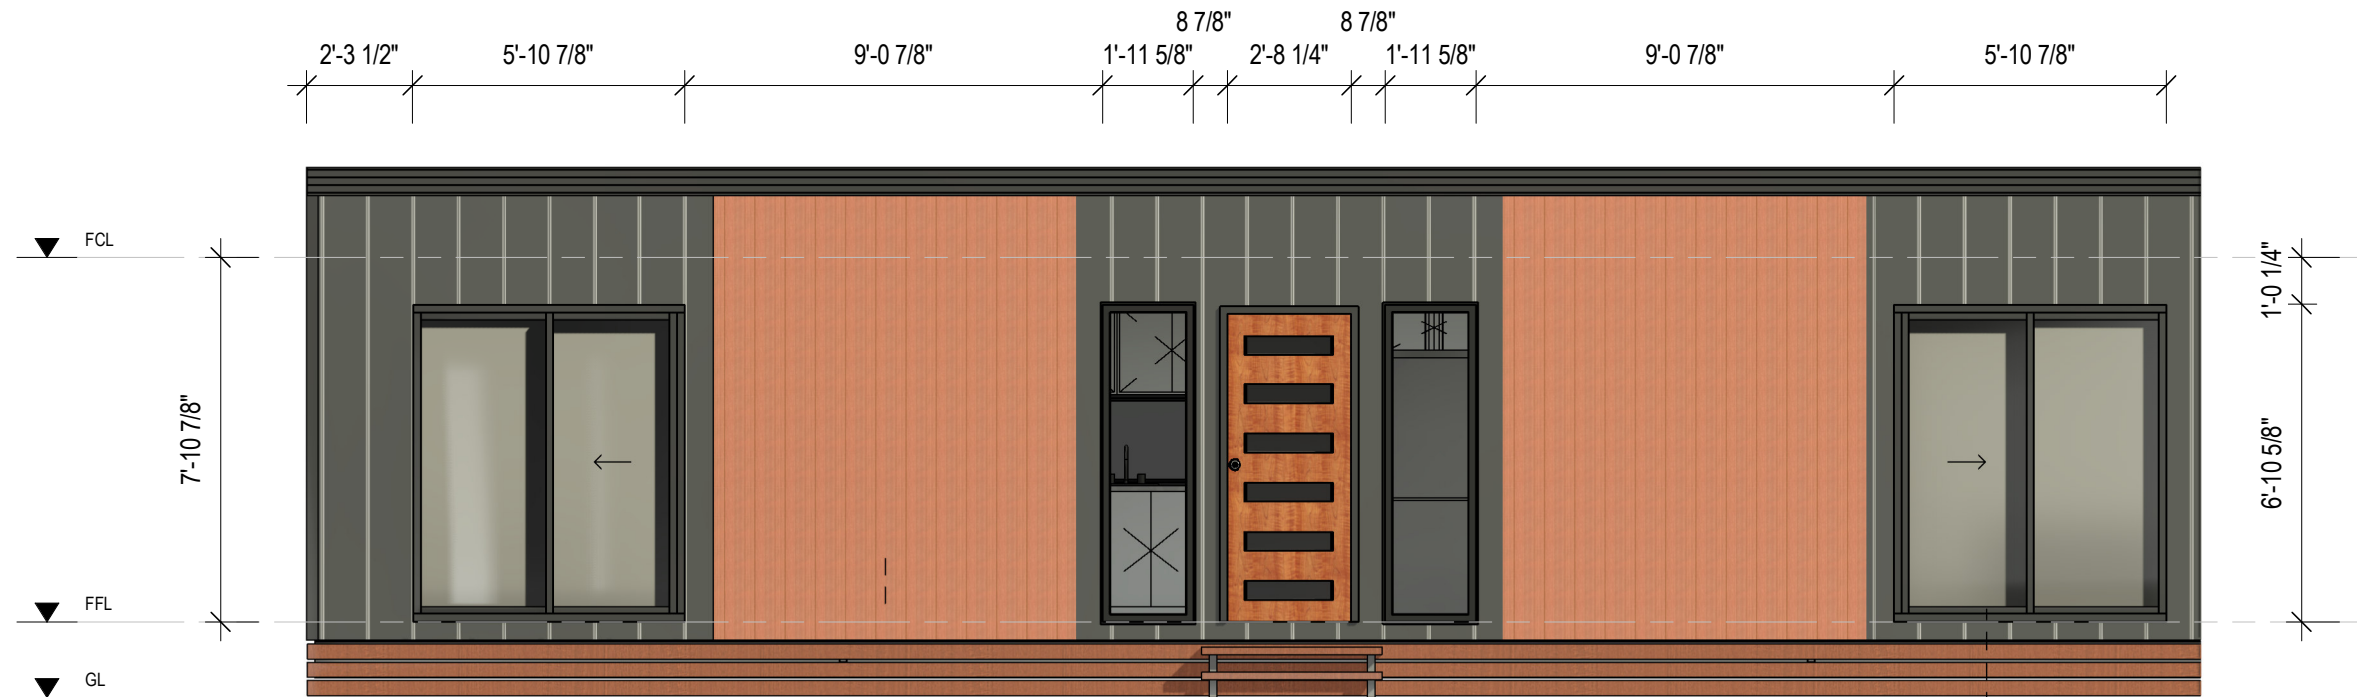

1 FRONT ELEVATION (1)

A102

1 : 50

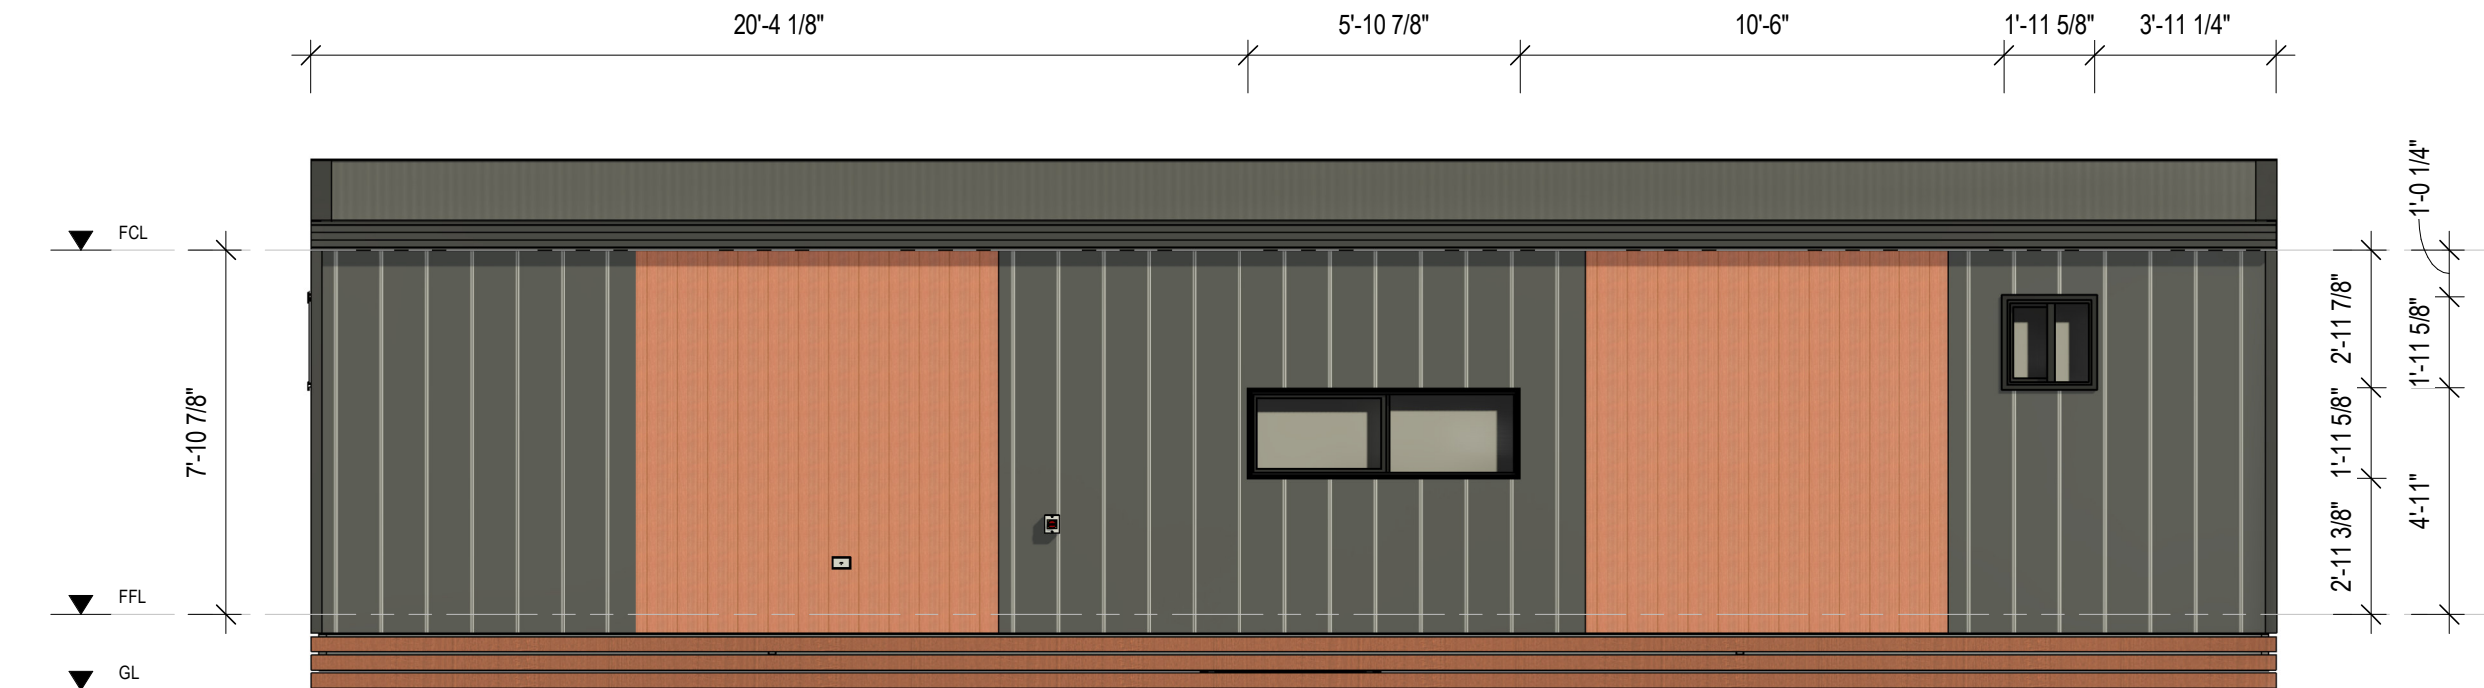


2 REAR ELEVATION (2)


A102

1 : 50

SET OUTS, LEVELS AND CRITICAL DIMENSIONS TO BE
CONFIRMED ON SITE PRIOR TO FABRICATION
DO NOT SCALE FROM THIS DRAWING, USE FIGURED
DIMENSIONS
ALL CONSTRUCTION TO COMPLY WITH NATIONAL
CONSTRUCTION CODE OF AUSTRALIA (NCC) AND
RELEVANT AUSTRALIAN STANDARDS
ALL DESIGNS © AJC PORTABLES, 2024

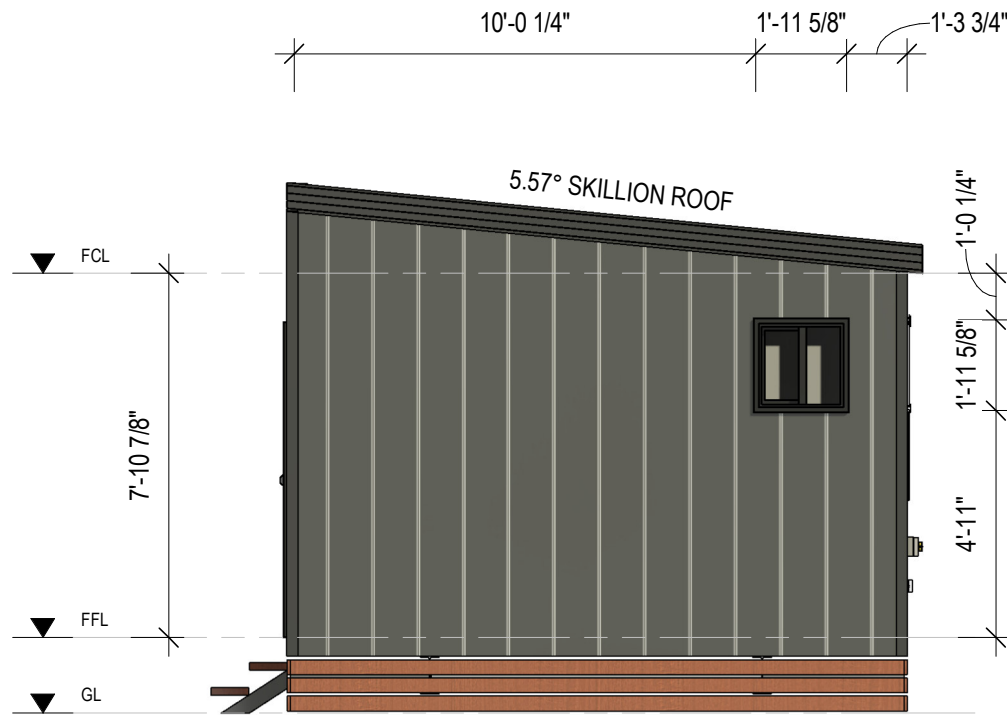

3 RIGHT ELEVATION (3)
A103 1 : 50

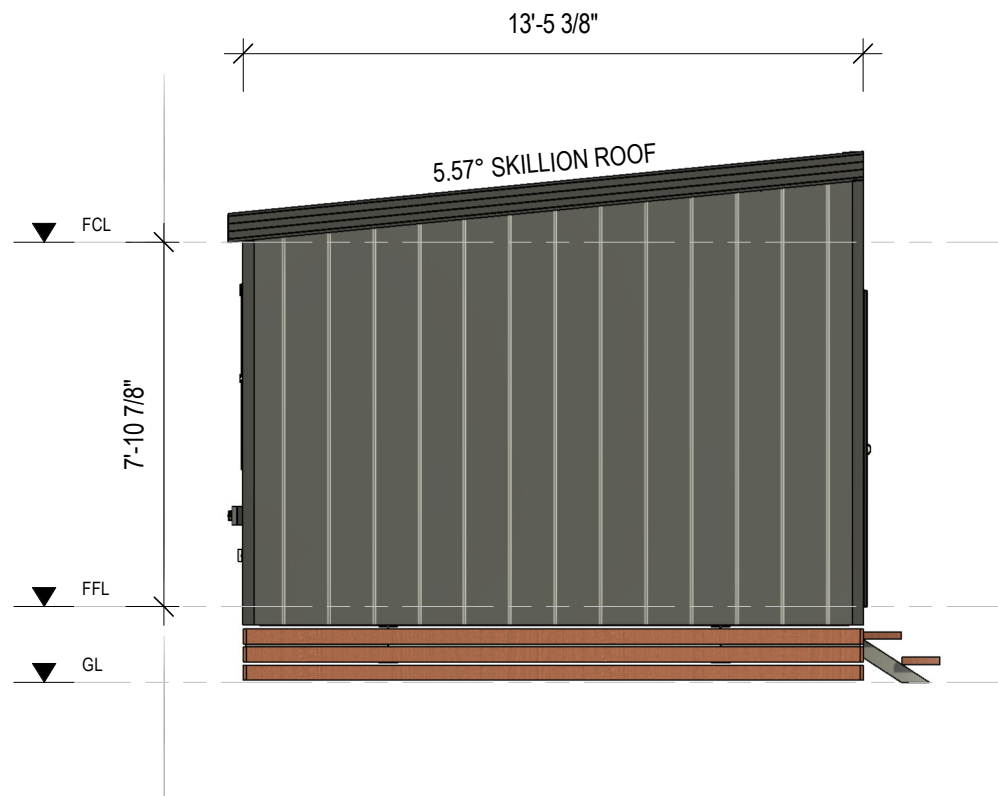

4 LEFT ELEVATION (4)
A103 1 : 50

REVISION SCHEDULE			
REV	DESCRIPTION	DATE	BY
A	ISSUED FOR REVIEW	28.03.26	DM
B	ADDED ELECTRICAL LAYOUT & PLUMBING LAYOUT	07.08.26	BV

DRAWING STATUS

**ISSUED FOR
REVIEW**

ORANA

14729 Spring Avenue,
Santa Fe Springs, CA, 90670
E: hello@oranausa.com
P: 888 256 6416

BUILDING NAME

'THE ESPERANCE'

DESCRIPTION

**13.0 x 4.1m 2 BEDROOM
CABIN**

CLIENT

ORANA

SHEET TITLE


ELEVATIONS 2 OF 2

DRAWING NUMBER

A103

REVISION
B
SCALE AT A3
1 : 50

12-Aug-26 8:22:05 AM

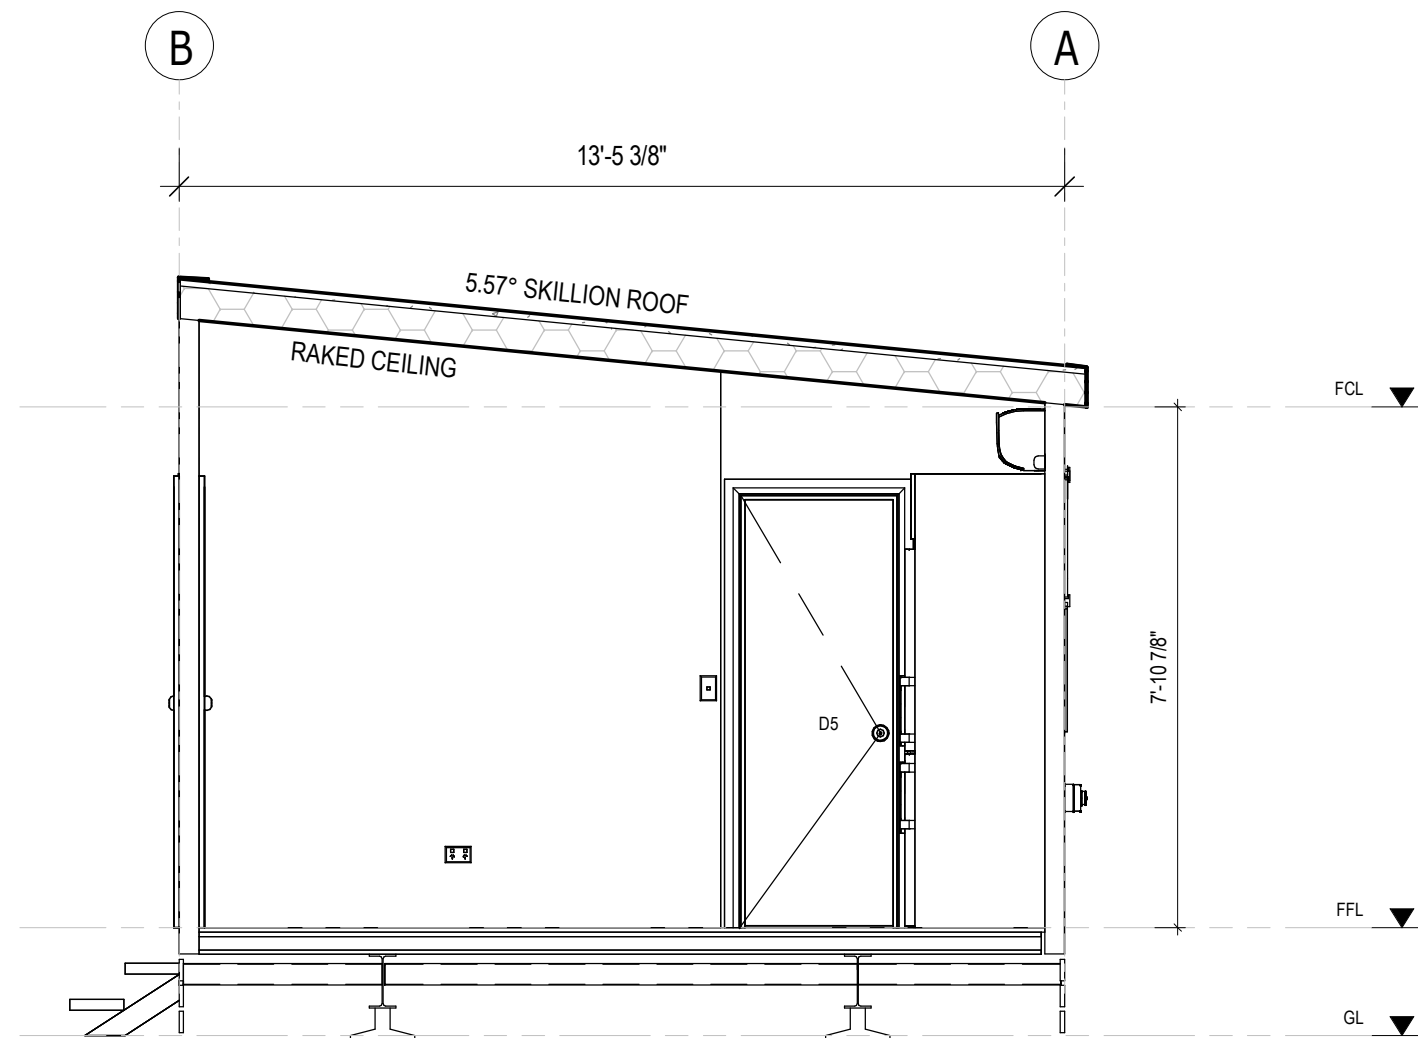

A SECTION A-A
A104 1 : 35

SET OUTS, LEVELS AND CRITICAL DIMENSIONS TO BE
CONFIRMED ON SITE PRIOR TO FABRICATION
DO NOT SCALE FROM THIS DRAWING, USE FIGURED
DIMENSIONS
ALL CONSTRUCTION TO COMPLY WITH NATIONAL
CONSTRUCTION CODE OF AUSTRALIA (NCC) AND
RELEVANT AUSTRALIAN STANDARDS
ALL DESIGNS © AJC PORTABLES, 2024

REVISION SCHEDULE			
REV	DESCRIPTION	DATE	BY
A	ISSUED FOR REVIEW	28.03.26	DM
B	ADDED ELECTRICAL LAYOUT & PLUMBING LAYOUT	07.08.26	BV

DRAWING STATUS

**ISSUED FOR
REVIEW**

ORANA

14729 Spring Avenue,
Santa Fe Springs, CA, 90670
E: hello@oranausa.com
P: 888 256 6416

BUILDING NAME

'THE ESPERANCE'

DESCRIPTION

**13.0 x 4.1m 2 BEDROOM
CABIN**

CLIENT

ORANA

SHEET TITLE

**SECTION & INTERNAL
3D VIEWS**

DRAWING NUMBER

A104

REVISION


B

SCALE AT A3


1 : 35

12-Aug-26 8:22:06 AM



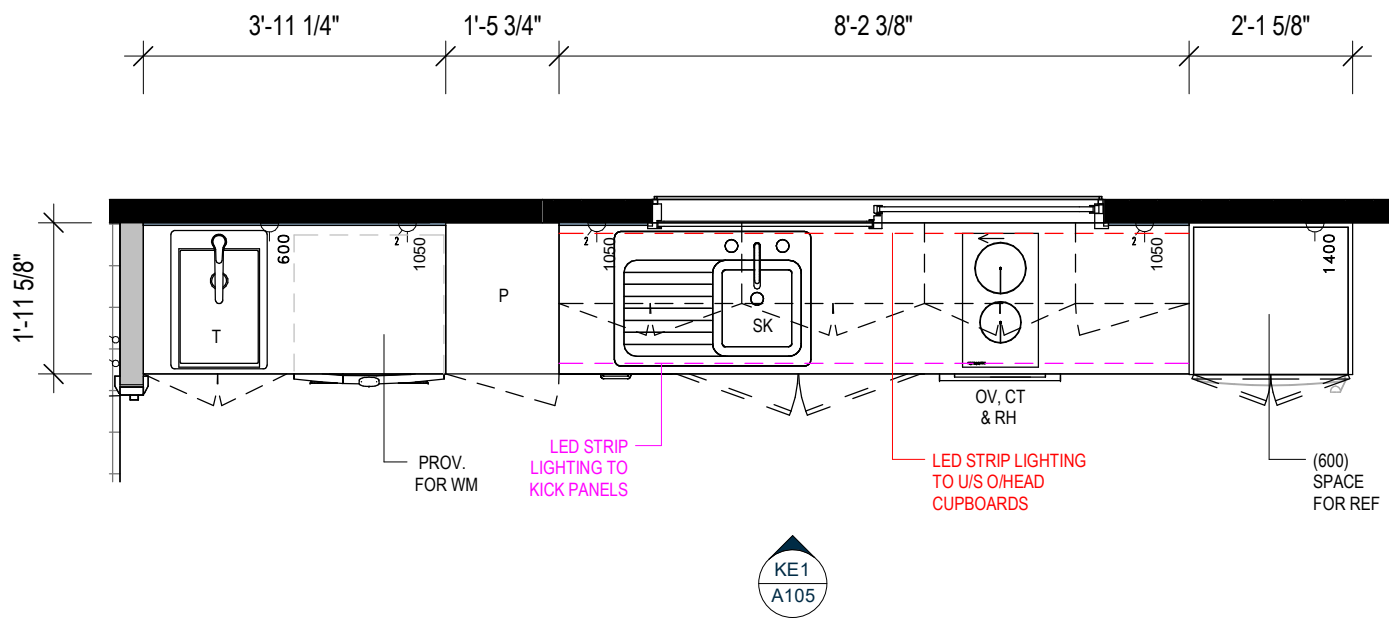

1 KITCHEN & LAUNDRY JOINERY - PLAN VIEW
A105 1 : 30

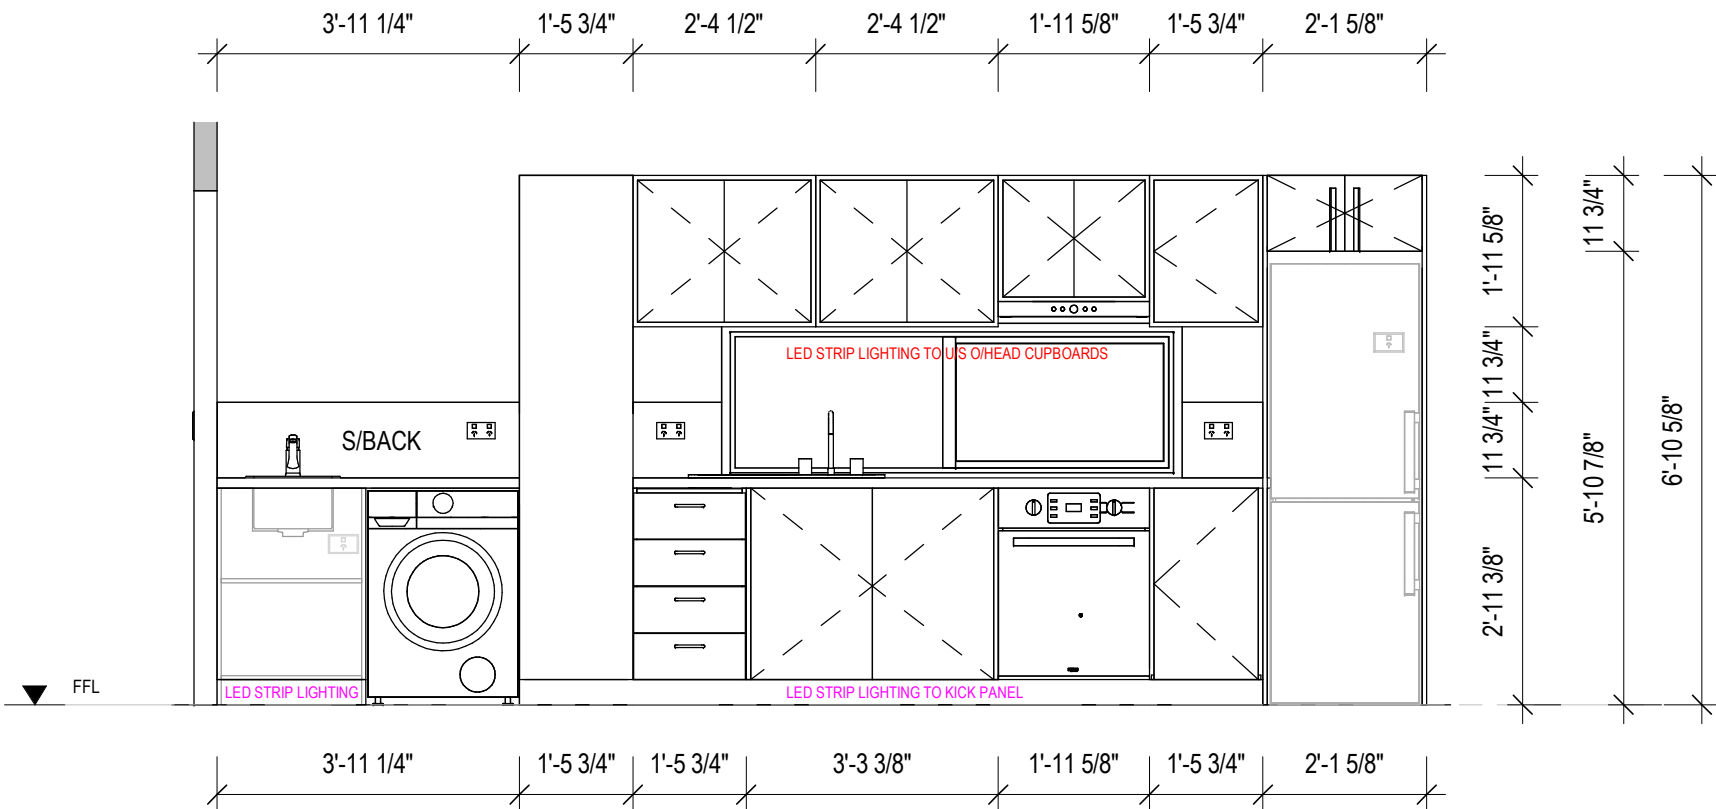

KE1 KITCHEN/LAUNDRY JOINERY ELEVATION 1 (KE1)
A105 1 : 30

KITCHEN JOINERY COLOURS

BENCHTOP: 'TBC' (30mm STONE)
SPLASHBACK: 'TBC'
CARCASSES: 'FLAT WHITE'
CUPBOARDS & DRAWER FRONTS:
UPPER: 'TBC'
LOWER: 'TBC'
KICK PANELS: 'TBC'

SET OUTS, LEVELS AND CRITICAL DIMENSIONS TO BE
CONFIRMED ON SITE PRIOR TO FABRICATION
DO NOT SCALE FROM THIS DRAWING, USE FIGURED
DIMENSIONS
ALL CONSTRUCTION TO COMPLY WITH NATIONAL
CONSTRUCTION CODE OF AUSTRALIA (NCC) AND
RELEVANT AUSTRALIAN STANDARDS
ALL DESIGNS © AJC PORTABLES, 2024

REVISION SCHEDULE			
REV	DESCRIPTION	DATE	BY
A	ISSUED FOR REVIEW	28.03.26	DM
B	ADDED ELECTRICAL LAYOUT & PLUMBING LAYOUT	07.08.26	BV

DRAWING STATUS

**ISSUED FOR
REVIEW**

ORANA

14729 Spring Avenue,
Santa Fe Springs, CA, 90670
E: hello@oranausa.com
P: 888 256 6416

BUILDING NAME

'THE ESPERANCE'

DESCRIPTION

**13.0 x 4.1m 2 BEDROOM
CABIN**

CLIENT

ORANA

SHEET TITLE

**JOINERY DETAILS,
KITCHEN & LAUNDRY**

DRAWING NUMBER

A105

REVISION

B

SCALE AT A3
1 : 30

12-Aug-26 8:22:06 AM

ELECTRICAL SYMBOL LEGEND

	ELECTRICAL SWITCHBOARD		GPO, 1 x 10AMP
	ELECTRICAL POINT OF ENTRY		GPO, 2 x 10AMP
	LIGHT SWITCH, SINGLE		20AMP AC ISOLATION SWITCH
	LIGHT SWITCH, TWO GANG		LED DOWNLIGHT
	LIGHT SWITCH, THREE GANG		240V SMOKE ALARM
	FAN/ LIGHT SWITCH		

SET OUTS, LEVELS AND CRITICAL DIMENSIONS TO BE
CONFIRMED ON SITE PRIOR TO FABRICATION
DO NOT SCALE FROM THIS DRAWING, USE FIGURED
DIMENSIONS
ALL CONSTRUCTION TO COMPLY WITH NATIONAL
CONSTRUCTION CODE OF AUSTRALIA (NCC) AND
RELEVANT AUSTRALIAN STANDARDS
ALL DESIGNS © AJC PORTABLES, 2024

REVISION SCHEDULE

REV	DESCRIPTION	DATE	BY
A	ISSUED FOR REVIEW	28.03.26	DM
B	ADDED ELECTRICAL LAYOUT & PLUMBING LAYOUT	07.08.26	BV

DRAWING STATUS

ISSUED FOR
REVIEW

ORANA

14729 Spring Avenue,
Santa Fe Springs, CA, 90670
E: hello@oranausa.com
P: 888 256 6416

BUILDING NAME

'THE ESPERANCE'

DESCRIPTION

13.0 x 4.1m 2 BEDROOM
CABIN

CLIENT

ORANA

SHEET TITLE

ELECTRICAL LAYOUT -
PART 1

DRAWING NUMBER


A111

REVISION

B

SCALE AT A3
As indicated

12-Aug-26 8:22:06 AM

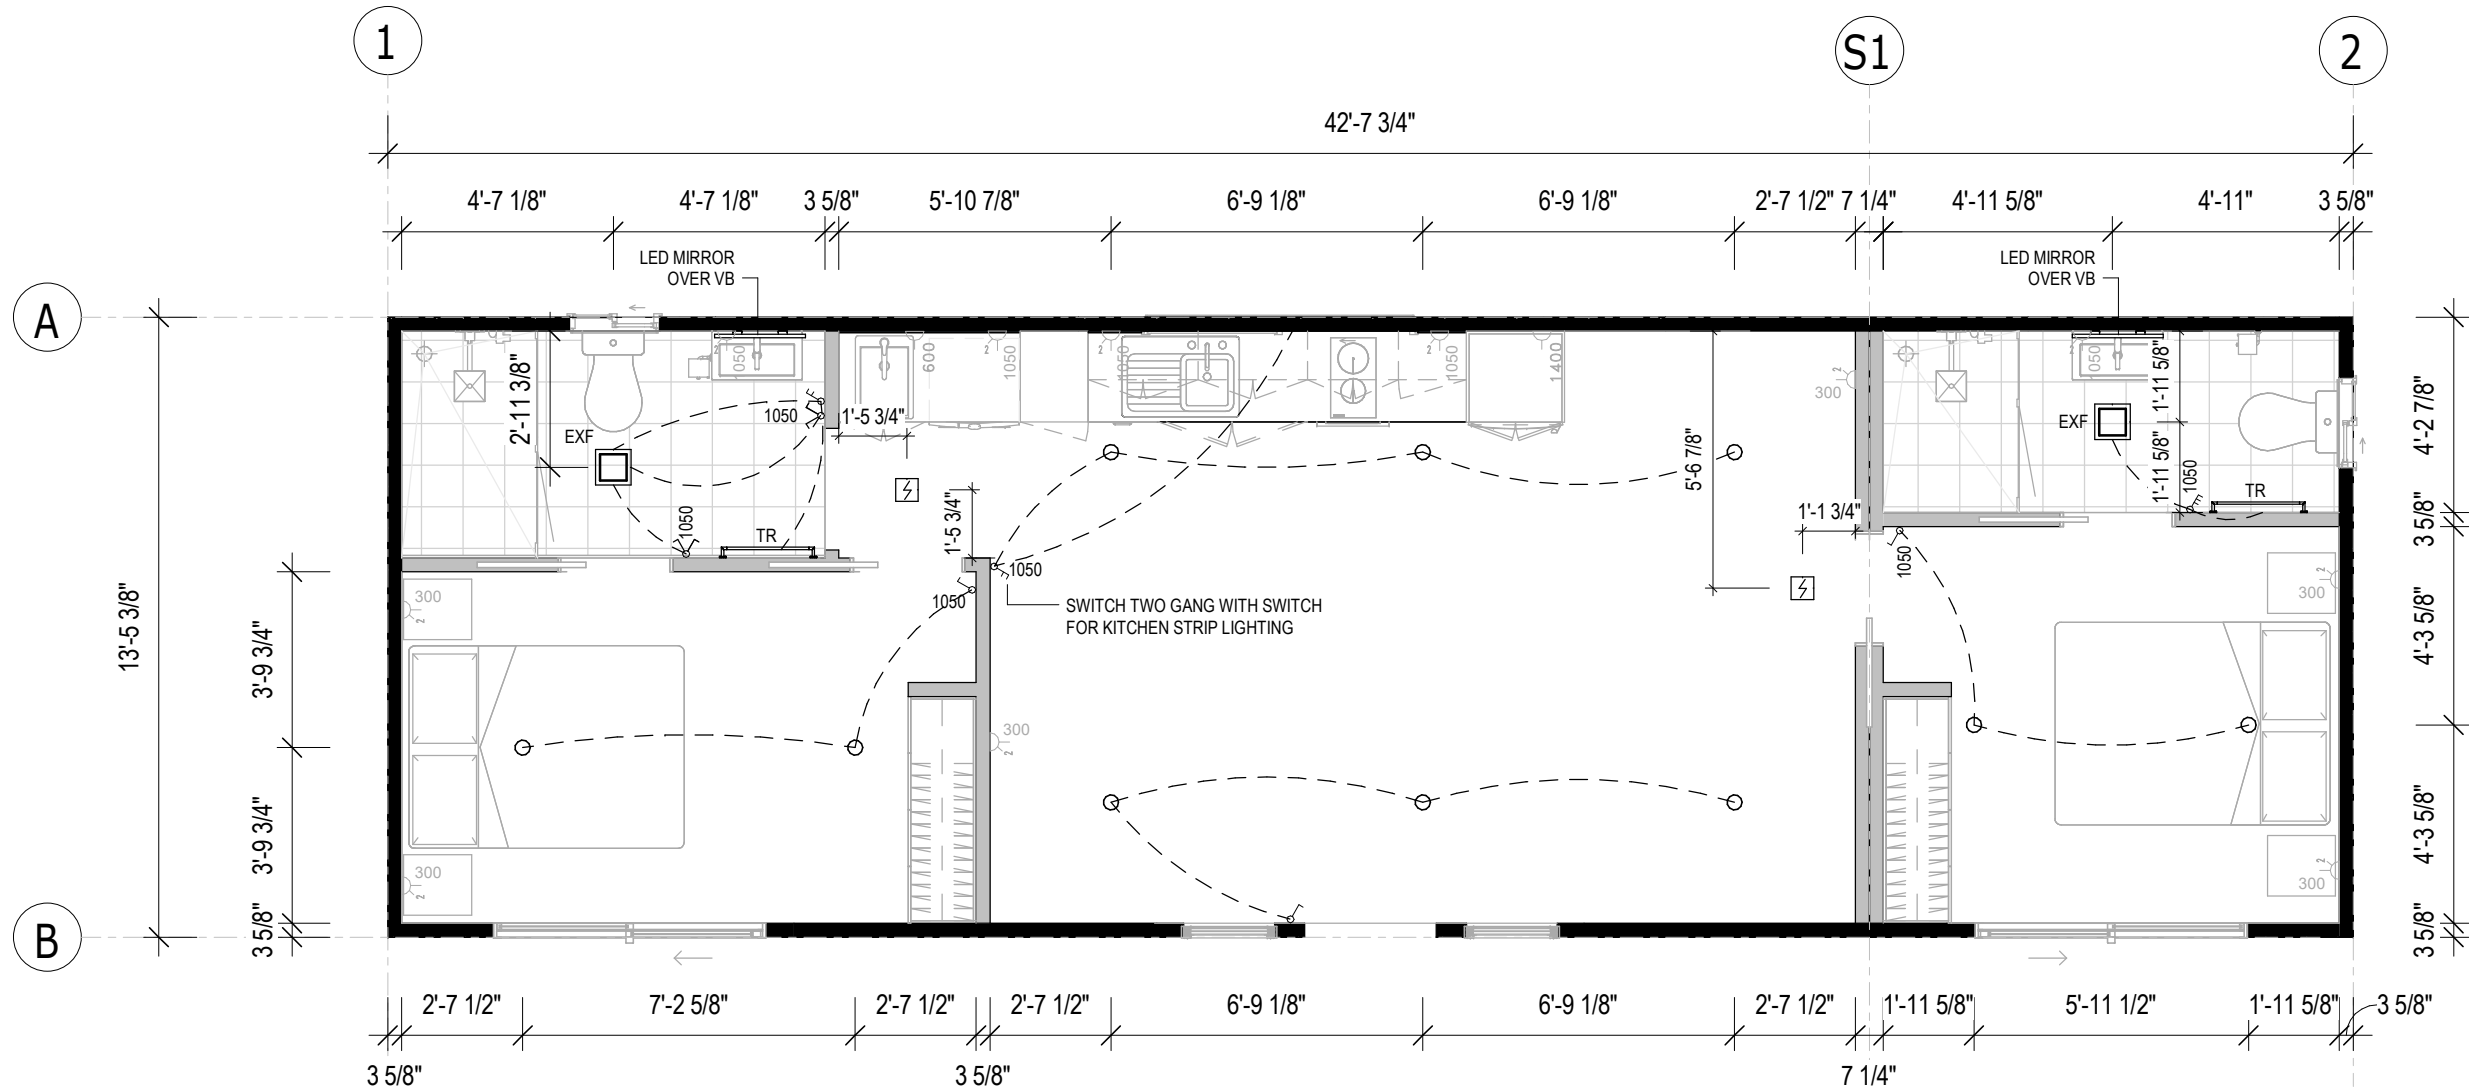

1

LIGHTING LAYOUT


A111

1 : 50

ELECTRICAL SYMBOL LEGEND

	ELECTRICAL SWITCHBOARD		GPO, 1 x 10AMP
	ELECTRICAL POINT OF ENTRY		GPO, 2 x 10AMP
	LIGHT SWITCH, SINGLE		20AMP AC ISOLATION SWITCH
	LIGHT SWITCH, TWO GANG		LED DOWNLIGHT
	LIGHT SWITCH, THREE GANG		240V SMOKE ALARM
	FAN/ LIGHT SWITCH		

SET OUTS, LEVELS AND CRITICAL DIMENSIONS TO BE
CONFIRMED ON SITE PRIOR TO FABRICATION
DO NOT SCALE FROM THIS DRAWING, USE FIGURED
DIMENSIONS
ALL CONSTRUCTION TO COMPLY WITH NATIONAL
CONSTRUCTION CODE OF AUSTRALIA (NCC) AND
RELEVANT AUSTRALIAN STANDARDS
ALL DESIGNS © AJC PORTABLES, 2024

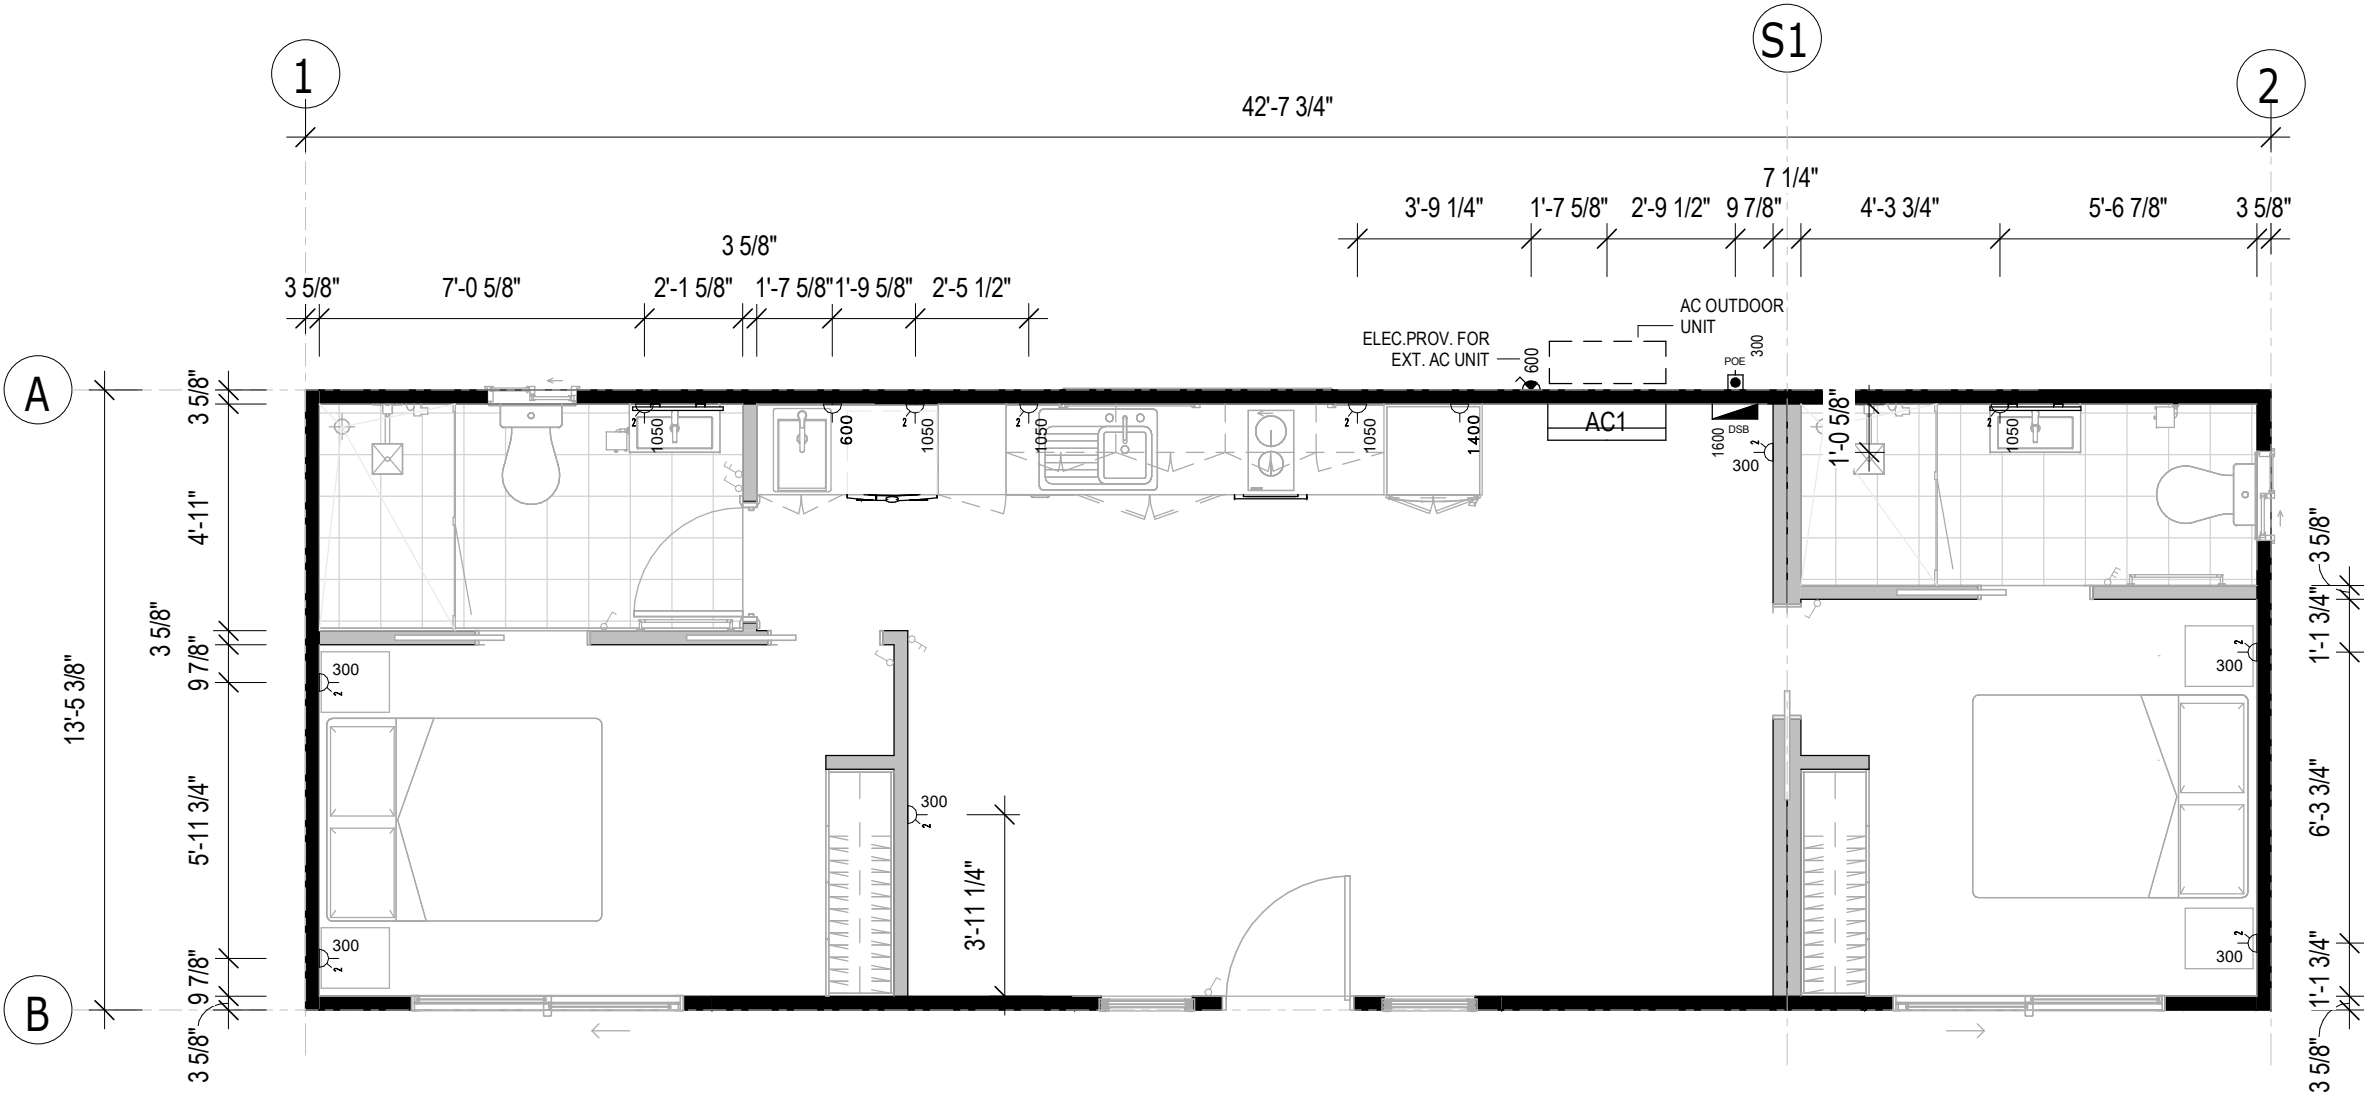

1 POWER LAYOUT
A112 1 : 50

SET OUTS, LEVELS AND CRITICAL DIMENSIONS TO BE
CONFIRMED ON SITE PRIOR TO FABRICATION
DO NOT SCALE FROM THIS DRAWING, USE FIGURED
DIMENSIONS
ALL CONSTRUCTION TO COMPLY WITH NATIONAL
CONSTRUCTION CODE OF AUSTRALIA (NCC) AND
RELEVANT AUSTRALIAN STANDARDS
ALL DESIGNS © AJC PORTABLES, 2024

REVISION SCHEDULE			
REV	DESCRIPTION	DATE	BY
A	ISSUED FOR REVIEW	28.03.26	DM
B	ADDED ELECTRICAL LAYOUT & PLUMBING LAYOUT	07.08.26	BV

DRAWING STATUS

ISSUED FOR
REVIEW

ORANA

14729 Spring Avenue,
Santa Fe Springs, CA, 90670
E: hello@oranausa.com
P: 888 256 6416

BUILDING NAME

'THE ESPERANCE'

DESCRIPTION

13.0 x 4.1m 2 BEDROOM
CABIN

CLIENT

ORANA

SHEET TITLE

ELECTRICAL LAYOUT -
PART 2

DRAWING NUMBER

A112

REVISION
B
SCALE AT A3
As indicated

12-Aug-26 8:22:06 AM

SET OUTS, LEVELS AND CRITICAL DIMENSIONS TO BE
CONFIRMED ON SITE PRIOR TO FABRICATION
DO NOT SCALE FROM THIS DRAWING, USE FIGURED
DIMENSIONS
ALL CONSTRUCTION TO COMPLY WITH NATIONAL
CONSTRUCTION CODE OF AUSTRALIA (NCC) AND
RELEVANT AUSTRALIAN STANDARDS
ALL DESIGNS © AJC PORTABLES, 2024

REVISION SCHEDULE			
REV	DESCRIPTION	DATE	BY
A	ISSUED FOR REVIEW	28.03.26	DM
B	ADDED ELECTRICAL LAYOUT & PLUMBING LAYOUT	07.08.26	BV

DRAWING STATUS

ISSUED FOR
REVIEW

ORANA

14729 Spring Avenue,
Santa Fe Springs, CA, 90670
E: hello@oranausa.com
P: 888 256 6416

BUILDING NAME

'THE ESPERANCE'

DESCRIPTION

13.0 x 4.1m 2 BEDROOM
CABIN

CLIENT

ORANA

SHEET TITLE

PLUMBING LAYOUT

DRAWING NUMBER

A113


REVISION

B

SCALE AT A3

1 : 50

12-Aug-26 8:22:07 AM

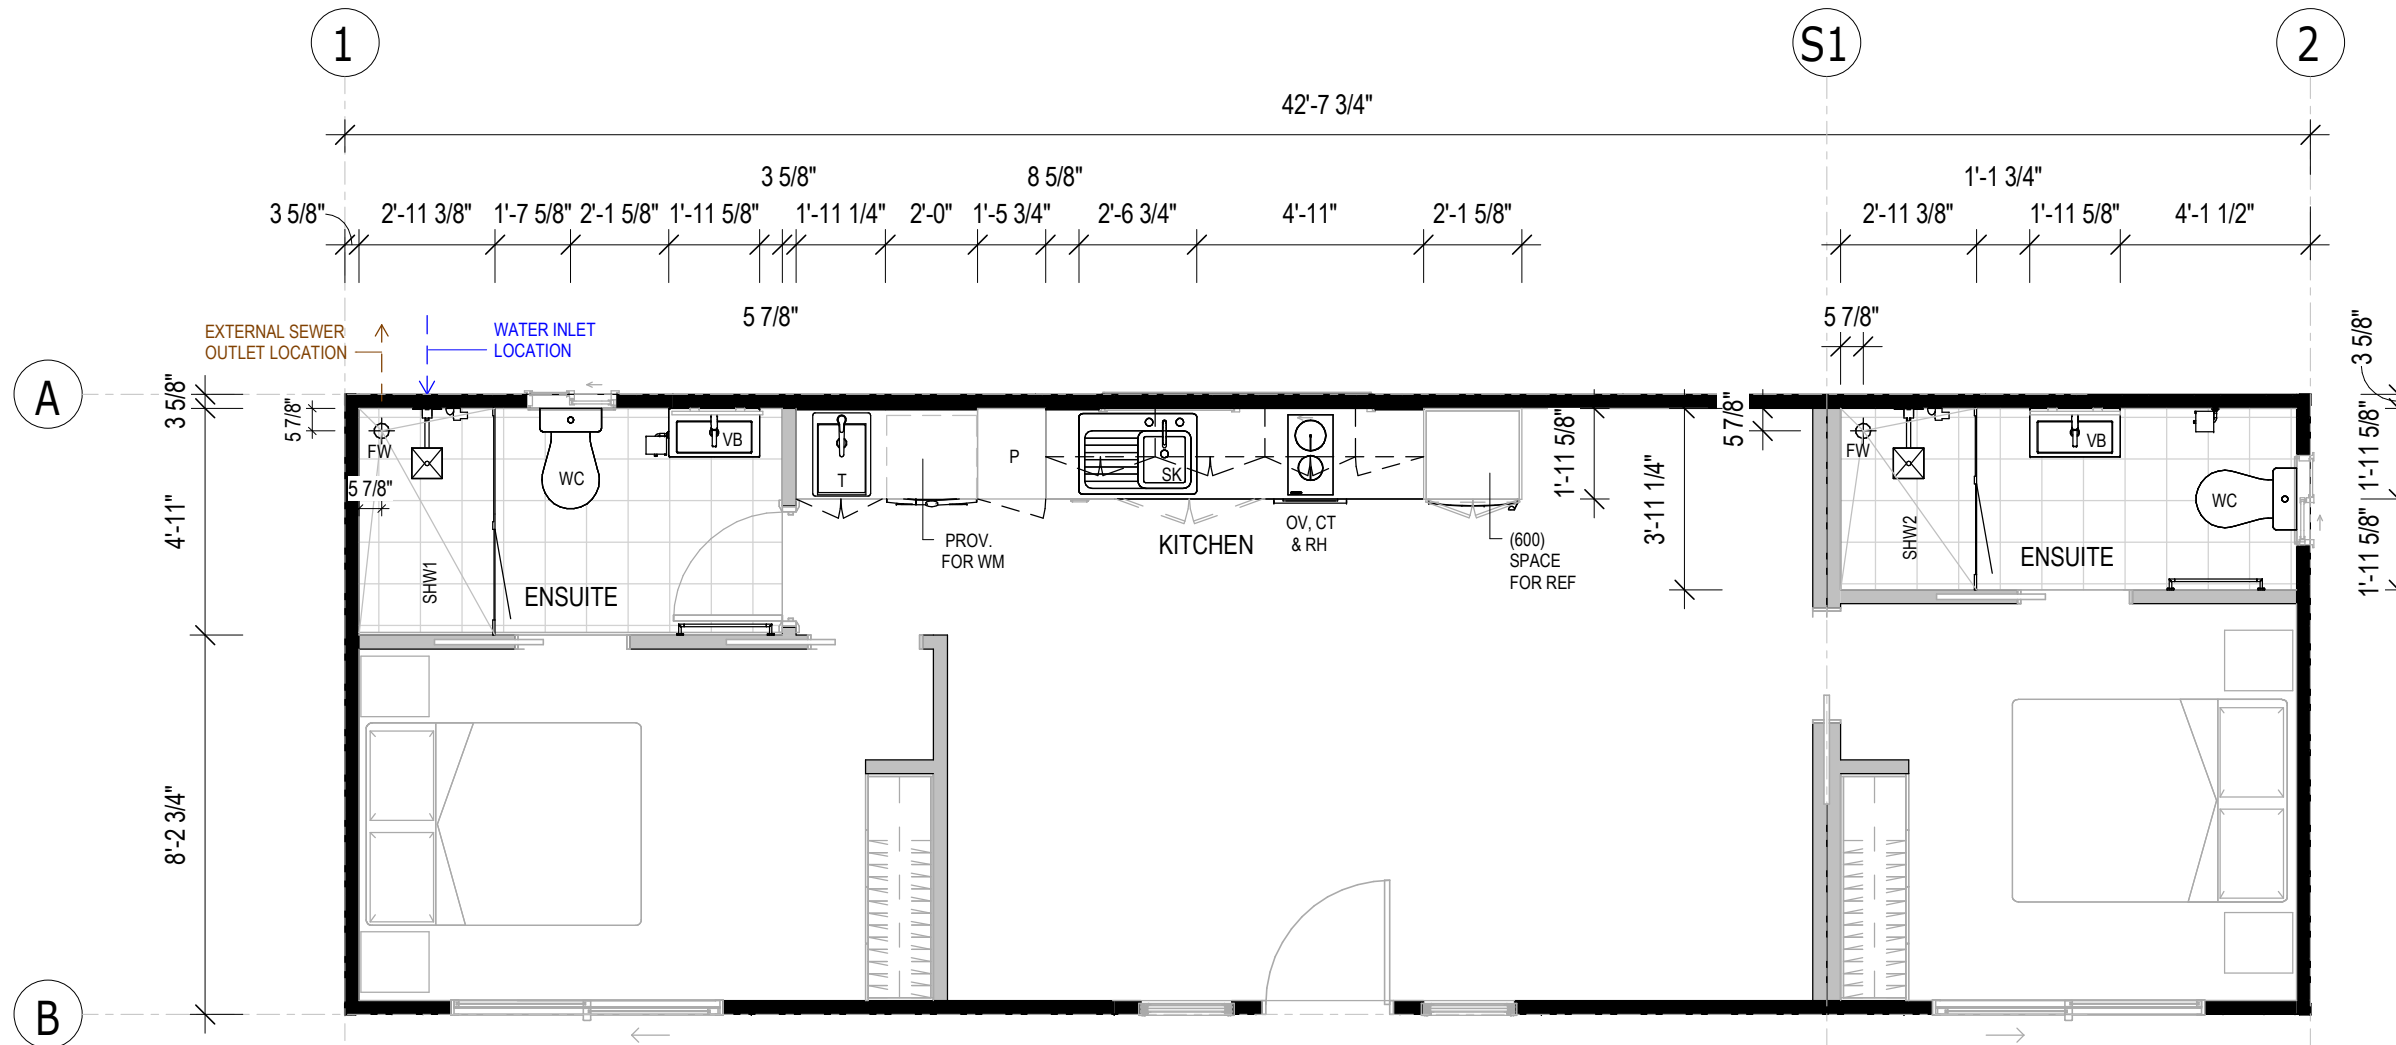

1 PLUMBING LAYOUT

A113

1 : 50

SUB-FLOOR SYSTEM

SKID BEAMS: W10x22 STEEL SKID BEAM SYSTEM

FLOOR SYSTEM

FLOOR FRAMING: 100 x 1.5mm LIPPED CHANNEL JOISTS @ 450mm CS
INSULATION - U/FLOOR: R15 (OR EQUIV.) MINIMUM INSULATION VALUE
FLOORING 3/4" STRUCTURAL PLYWOOD
FLOOR COVERING: SPC PLANKS (STONE PLASTIC COMPOSITE CORE)

WALL SYSTEM

FRAMING: 92mm (OR EQUIV.) ENGINEERED STEEL FRAME

INSULATION: R15 (OR EQUIV.) MINIMUM INSULATION VALUE TO INTERNAL AND EXTERNAL WALLS

CLADDING: CHOICE OF THE FOLLOWING THEMES -
'MODERN'
'CONTEMPORARY'
'HAMPTONS'
'TRADITIONAL'

INTERNAL: 5/8" DRYWALL, SET & PAINTED

BATHROOM: LINED WITH SPC SHEETS

ROOF SYSTEM

ROOF SYSTEM: ENGINEERED STEEL FRAME/RAFTER SYSTEM
INSULATION: R19 (OR EQUIV.) BATTS + R9 (OR EQUIV.) BLANKET OVER. TOTAL MINIMUM INSULATION VALUE = R26
STEEL PANEL ROOFING
ROOFING: STEEL PANEL ROOFING
INTERNAL: 5/8" DRYWALL, SET & PAINTED (SQUARE SET)

FINISHES SCHEDULE

ITEM	COLOUR	
FLOOR COVERING:		
SPC PLANKS	'TBC'	(GENERALLY)
FLOOR TILES	'TBC'	(BATHROOM)
CARPET	'TBC'	(BEDROOMS)
CLADDING		
CORNER ANGELS	'TBC'	
INTERNAL FEATURE WALLS:		
LIVING AREA	'TBC'	
BEDROOMS	'TBC'	
BATHROOM WALLS	'TBC'	
WALLS, GENERALLY	'BRIGHT WHITE' MATTE	(STANDARD)
CEILING	'BRIGHT WHITE' MATTE	(STANDARD)
ROOF:		
ROOF SHEET	'SHALE GREY'	
GUTTER	NIL - N/A	
FASCIA	'TBC'	
EXTERNAL DOOR:		
SWING DOOR FRAME	'TBC'	(TIMBER)
DOOR BLANK	'N/A'	
WINDOWS		
WINDOW FRAMES	'TBC'	(uPVC)

DOOR SCHEDULE									
No.	DOOR LEAF			DOOR FRAME	DOOR HARDWARE			QTY	COMMENTS
			SIZE	FRAME	HANDLE TYPE	LOCKSET	CLOSER		
	DOOR LEAF	H	W						
D1	SOLID CORE	2040	820	TIMBER	KNOB	ENTRANCE	No	1	/W GLASS PANELS
D2a	SLIDING GLASS DOOR	2100	1800	uPVC	'D'	ENTRANCE	No	1	DOUBLE GLAZED
D2b	SLIDING GLASS DOOR	2100	1800	uPVC	'D'	ENTRANCE	No	1	DOUBLE GLAZED
D3	HOLLOW CORE	2040	720	TIMBER	CAV	PASSAGE	No	2	CAVITY SLIDER
D4	HOLLOW CORE	2040	720	TIMBER	CAV	PRIVACY	No	2	CAVITY SLIDER
D5	HOLLOW CORE	2040	720	TIMBER	KNOB	PRIVACY	No	1	

WINDOW SCHEDULE									
No.	TYPE	GLAZING	SIZE		SILL HEIGHT	FRAME	SECURITY	QTY	COMMENTS
			H	W					
W1	SLIDING	OBSCURE GLASS	600	600	1500	uPVC	-	2	DOUBLE GLAZED
W2	FIXED	CLEAR GLASS	600	1800	900	uPVC	-	1	DOUBLE GLAZED
W3	SLIDING	CLEAR GLASS	2100	600	0	uPVC	-	2	DOUBLE GLAZED

MECHANICAL SERVICES SCHEDULE			
No.	DESCRIPTION	QTY	COMMENTS
EXF	2 IN 1 EXHAUST FAN AND LIGHT COMBO	2	CEILING MOUNTED
AC1	2.6kW SPLIT SYSTEM AC UNIT	1	CONDENSING UNITS TO BE INSTALLED ON SITE
RH	UNDERMOUNT RANGEHOOD, 60cm	1	

FITTINGS SCHEDULE		
ITEM	DESCRIPTION	QTY
Electrical Fixtures		
-	GPO, 1x10A	2
-	GPO, 2x10A	11
-	ISOLATION SWITCH 1x20A FOR AIR CONDITIONER (WP)	1
-	SMOKE DETECTOR 120V, HARDWIRED WITH BATTERY BACKUP	2
DSB	SWITCHBOARD & ELEC. POINT OF ENTRY	1
Lighting Fixtures		
-	DOWNLIGHT - LED	10
-	LIGHT SWITCH, SINGLE	3
-	LIGHT SWITCH, TWO GANG	2
-	LIGHT SWITCH, THREE GANG	1
-	LIGHT SWITCH, TWO WAY	2
Plumbing Fixtures		
-	LAUNDRY MIXER TAP	1
-	RAIL SHOWER WITH HEAD AND WAND	2
-	SHOWER MIXER TAP	2
-	WASHING MACHINE TAPSET	1

FITTINGS SCHEDULE		
ITEM	DESCRIPTION	QTY
FW	FLOOR WASTE	2
SHW1	SEMI FRAMELESS GLASS SHOWER SCREEN, 1500 x 900mm	1
SHW2	SEMI FRAMELESS GLASS SHOWER SCREEN, 1200 x 900mm	1
SK	SINK, 1 BOWL, 1 DRAIN - 780mm LONG	1
T	COMPACT LAUNDRY TUB, 35L	1
VB	VANITY, 2 DOOR - 600W x 320D (TEAK OAK FINISH)	2
WC	WC SUITE, RIMLESS, BTW, (CERAMIC BOWL)	2
Specialty Equipment		
CT	2 BURNER ELECTRIC COOKTOP	1
MIR	WALL MOUNTED LED MIRROR	2
OV	60cm ELECTRIC BUILT-IN OVEN	1
REF	PROVISION FOR FRIDGE	1
TR	HEATED TOWER RAIL, 600mm LONG	2
TRH	TOILET ROLL HOLDER	2
WM	PROVISION FOR WASHING MACHINE	1

INCLUSIONS ARE INDICATIVE ONLY, TO BE DISCUSSED
TAPWARE FOR SINK, VANITIES, TOWEL RAIL, TOILET ROLL HOLDER, SHOWER HEAD AND RAIL - GRAPHITE (STANDARD)
KITCHEN SINK - GRAPHITE (STANDARD)

SET OUTS, LEVELS AND CRITICAL DIMENSIONS TO BE
CONFIRMED ON SITE PRIOR TO FABRICATION
DO NOT SCALE FROM THIS DRAWING, USE FIGURED
DIMENSIONS
ALL CONSTRUCTION TO COMPLY WITH NATIONAL
CONSTRUCTION CODE OF AUSTRALIA (NCC) AND
RELEVANT AUSTRALIAN STANDARDS
ALL DESIGNS © AJC PORTABLES, 2024

REVISION SCHEDULE			
REV	DESCRIPTION	DATE	BY
A	ISSUED FOR REVIEW	28.03.26	DM
B	ADDED ELECTRICAL LAYOUT & PLUMBING LAYOUT	07.08.26	BV

DRAWING STATUS

ISSUED FOR
REVIEW

ORANA

14729 Spring Avenue,
Santa Fe Springs, CA, 90670
E: hello@oranausa.com
P: 888 256 6416

BUILDING NAME

'THE ESPERANCE'

DESCRIPTION
13.0 x 4.1m 2 BEDROOM
CABIN

CLIENT
ORANA

SHEET TITLE
SCHEDULES

DRAWING NUMBER
A120
REVISION
B
SCALE AT A3
1 : 5

12-Aug-26 8:22:07 AM